




Monitoring station - Bouwtekening

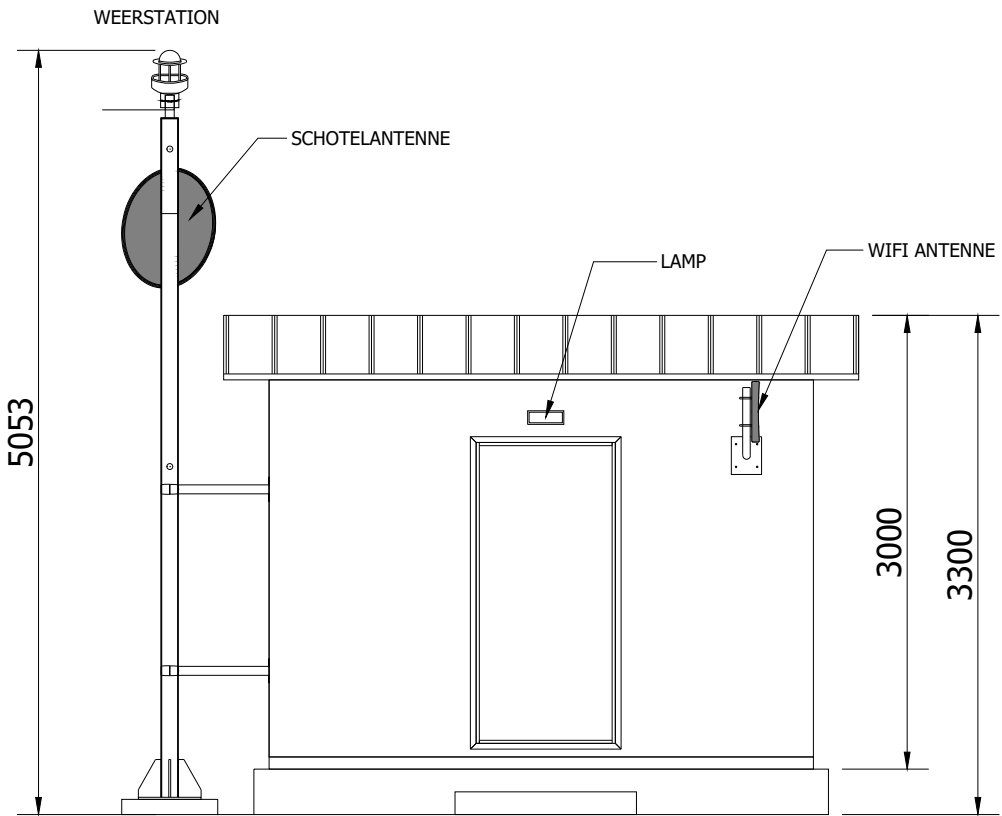


VOORAANZICHT

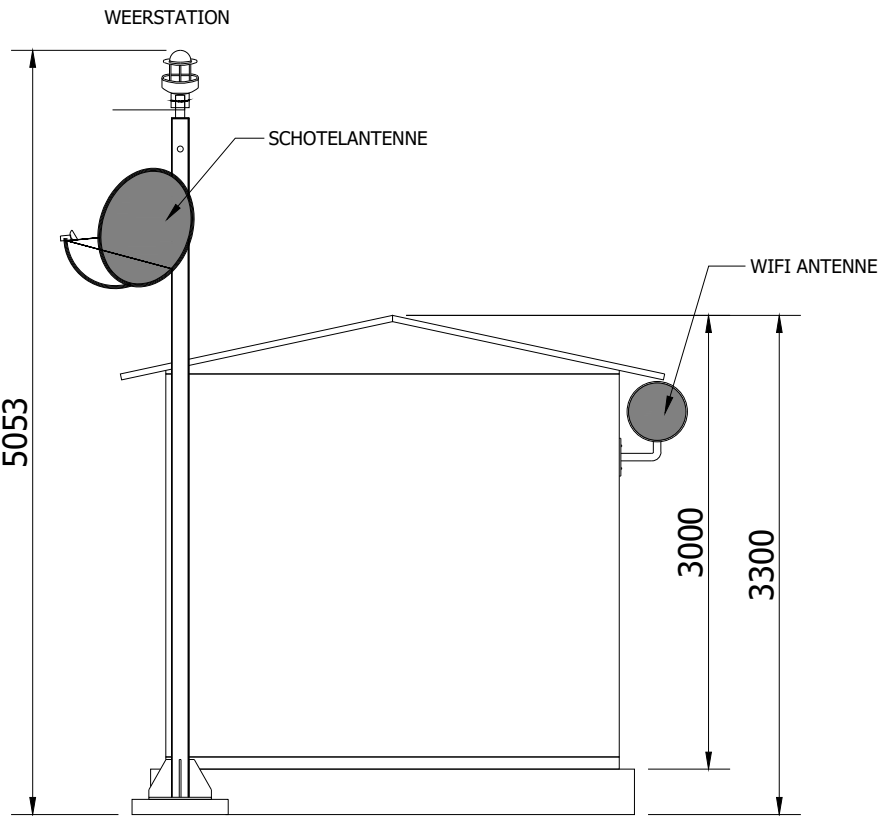

ZIJAAANZICHT

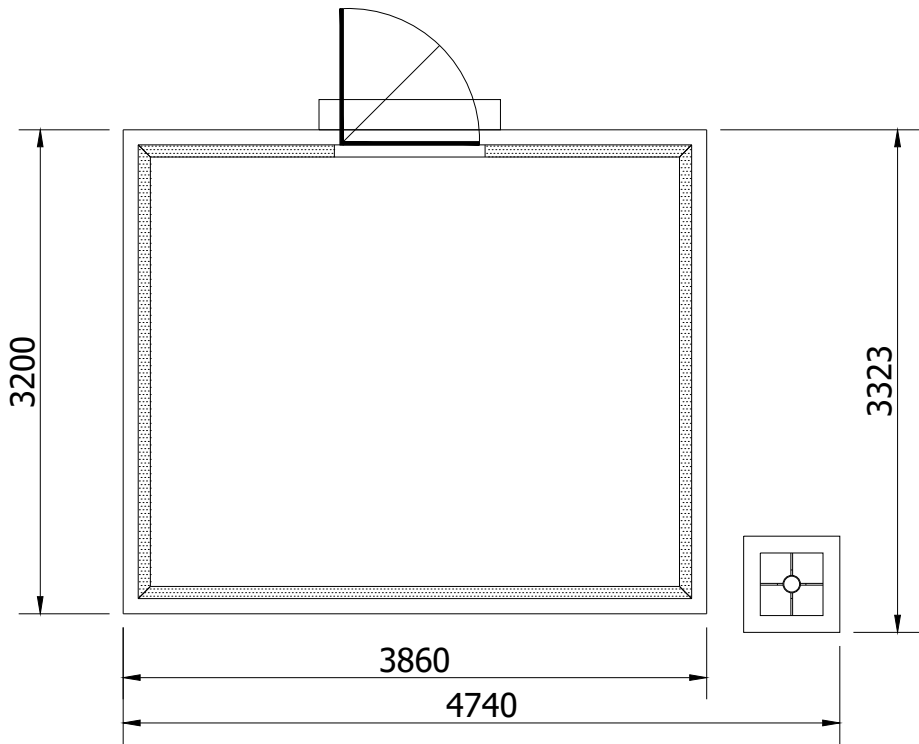

PLATTEGROND

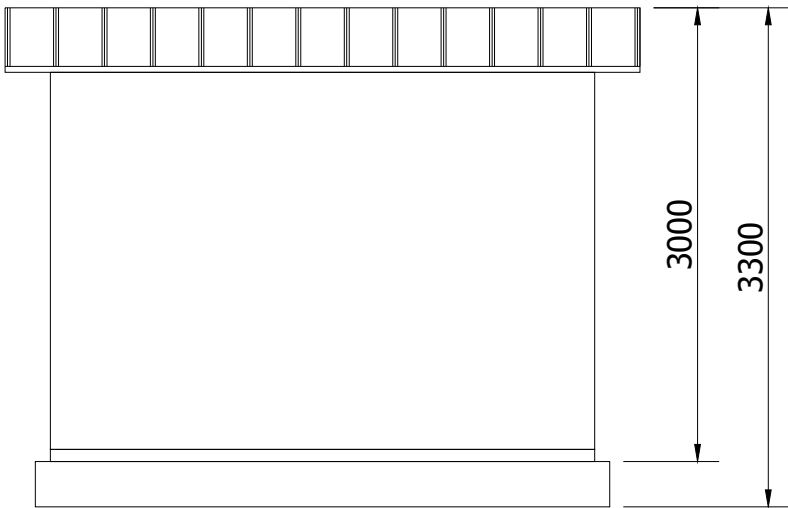

ACHTERAANZICHT



Referentiebeeld - Monitoring station



Referentiebeeld - Monitoring station



Referentiebeeld - Monitoring station

Kleurcodering gevel

RAL 6005 Moss Green

Monitoring station – Bouwtekening			
DA			15.08.19
DRAWN	CHECKED	APPROVED	DATE
Paper Size: A3	Scale: 1:50@A3	Sheet: 1	
DRAWING NUMBER: MTH_01		STATUS: Preliminary	

lightsourcebp

Lightsource Renewable Energy Netherlands Development B.V.
Gustav Mahlerlaan 1212, 1081 LA, Amsterdam
Tel: 085-0656 931
Email: nl.info@lightsourcebp.com
Web: www.lightsourcebp.com

THIS DOCUMENT IS THE PROPERTY OF LIGHTSOURCE RENEWABLE ENERGY NETHERLANDS HOLDINGS B.V.
IT IS PROHIBITED TO REPRODUCE IT FOR OTHER PURPOSES WITHOUT AUTHORIZATION IN WRITING